

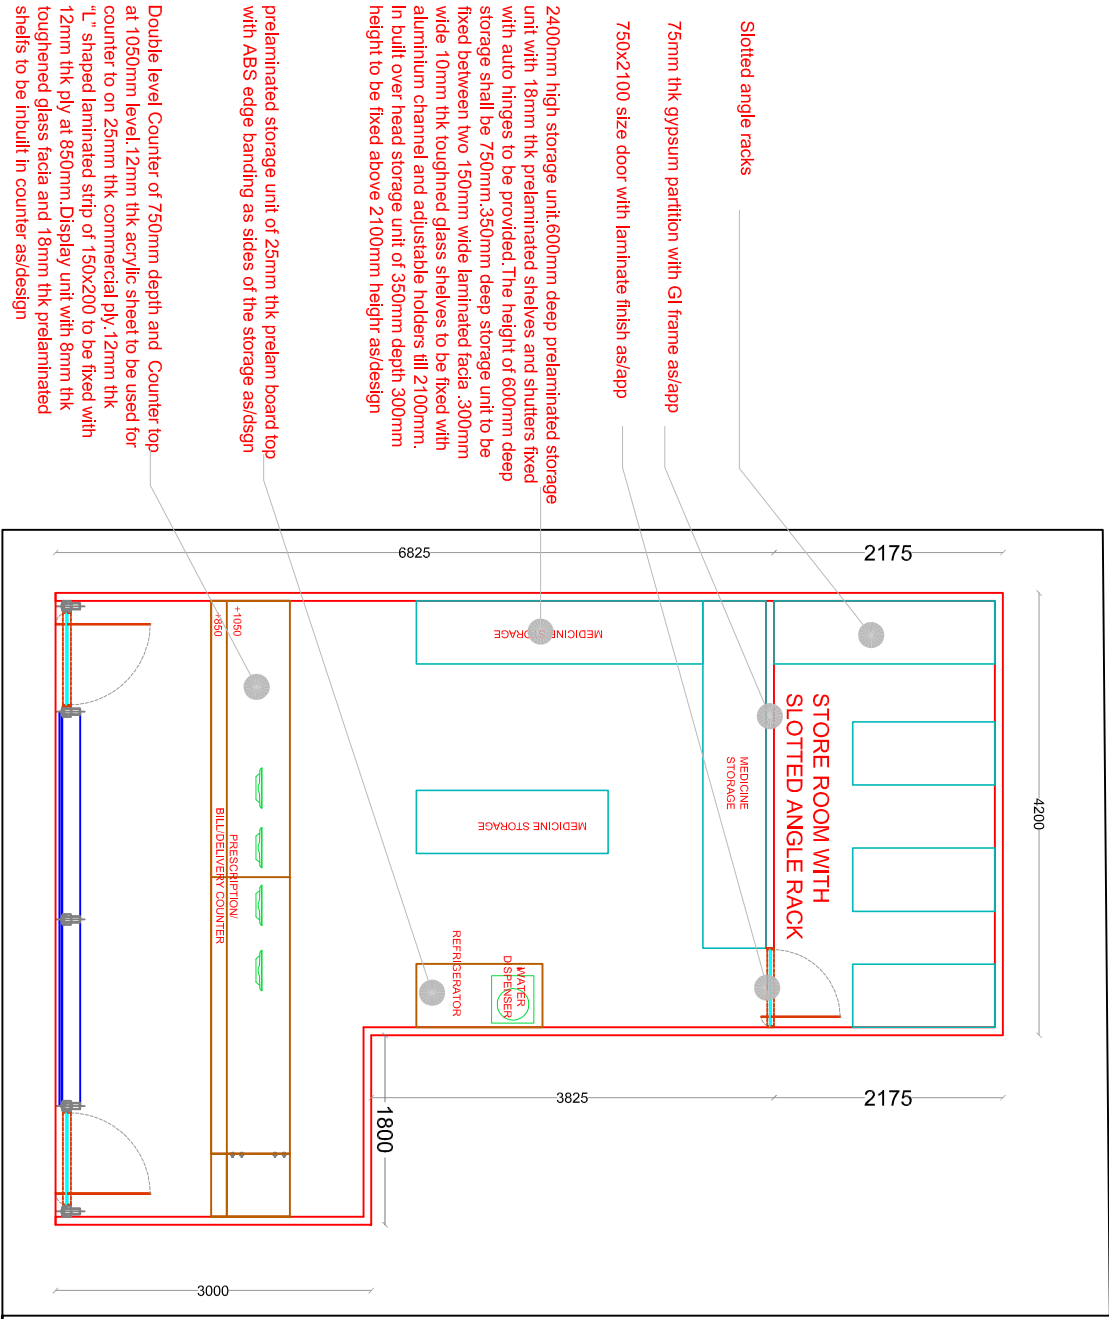


ELECTRICAL LEGEND		
Symbol	Description	HEIGHT OF FFL
	2X28W T-5 LIGHT FIXTURE	CEILING
	3X14W T-5 LIGHT FIXTURE	CEILING
	2NOS.DATA AND 1NO.VOICE OUTLET	230
	4NOS.13AMP UNIVERSAL SOCKET (UPS) WITH 1NO.16AMP SWITCH	230
	1NO.16AMP UNIVERSAL SOCKET (RAW) WITH 1NO.16AMP SWITCH	230
	DISTRIBUTION BOARD (LIGHT,POWER & UPS)	1500
	SWITCH BOARD	1050
	CCTV CAMERA	CEILING
	SMOKE DETECTOR BELOW FALSE CEILING	CEILING
	2WATT SPEAKER FOR PA SYSTEM	CEILING
	SMOKE DETECTOR ABOVE FALSE CEILING WITH RI	CEILING
	20A SWITCH SOCKET FOR AC	AS PER SITE
	CEILING FAN	CEILING




DWG. NO : <b>P(60) T001</b>		REV NO : <b>01</b>	DMS DESIGNS C1-2777, Sushant lok –I, Gurgaon – 122009 Tel:+91-124-4227638 Email:info@dmsdesigns.co.in Web: www.dmsdesigns.co.in	 humans being workspace
DWG. TITLE : <b>ELECTRICAL LAYOUT</b>		<b>PROJECT : PROPOSED LAYOUT OUT FOR AMRIT PHARMACY SAFDARJUNG HOSPITAL</b>		
Scale : <b>1:50</b>	<b>PROJECT :</b>			
Checked By : <b>Jc</b>				
Dealt By : <b>JS</b>				
Date : <b>02.02.16</b>	<b>STAGE : TENDER</b>	REGISTERED :THIS DRAWING IS AN OFFICIAL PROPERTY OF DMS DESIGNS & CONSULTANTS-NEW DELHI		

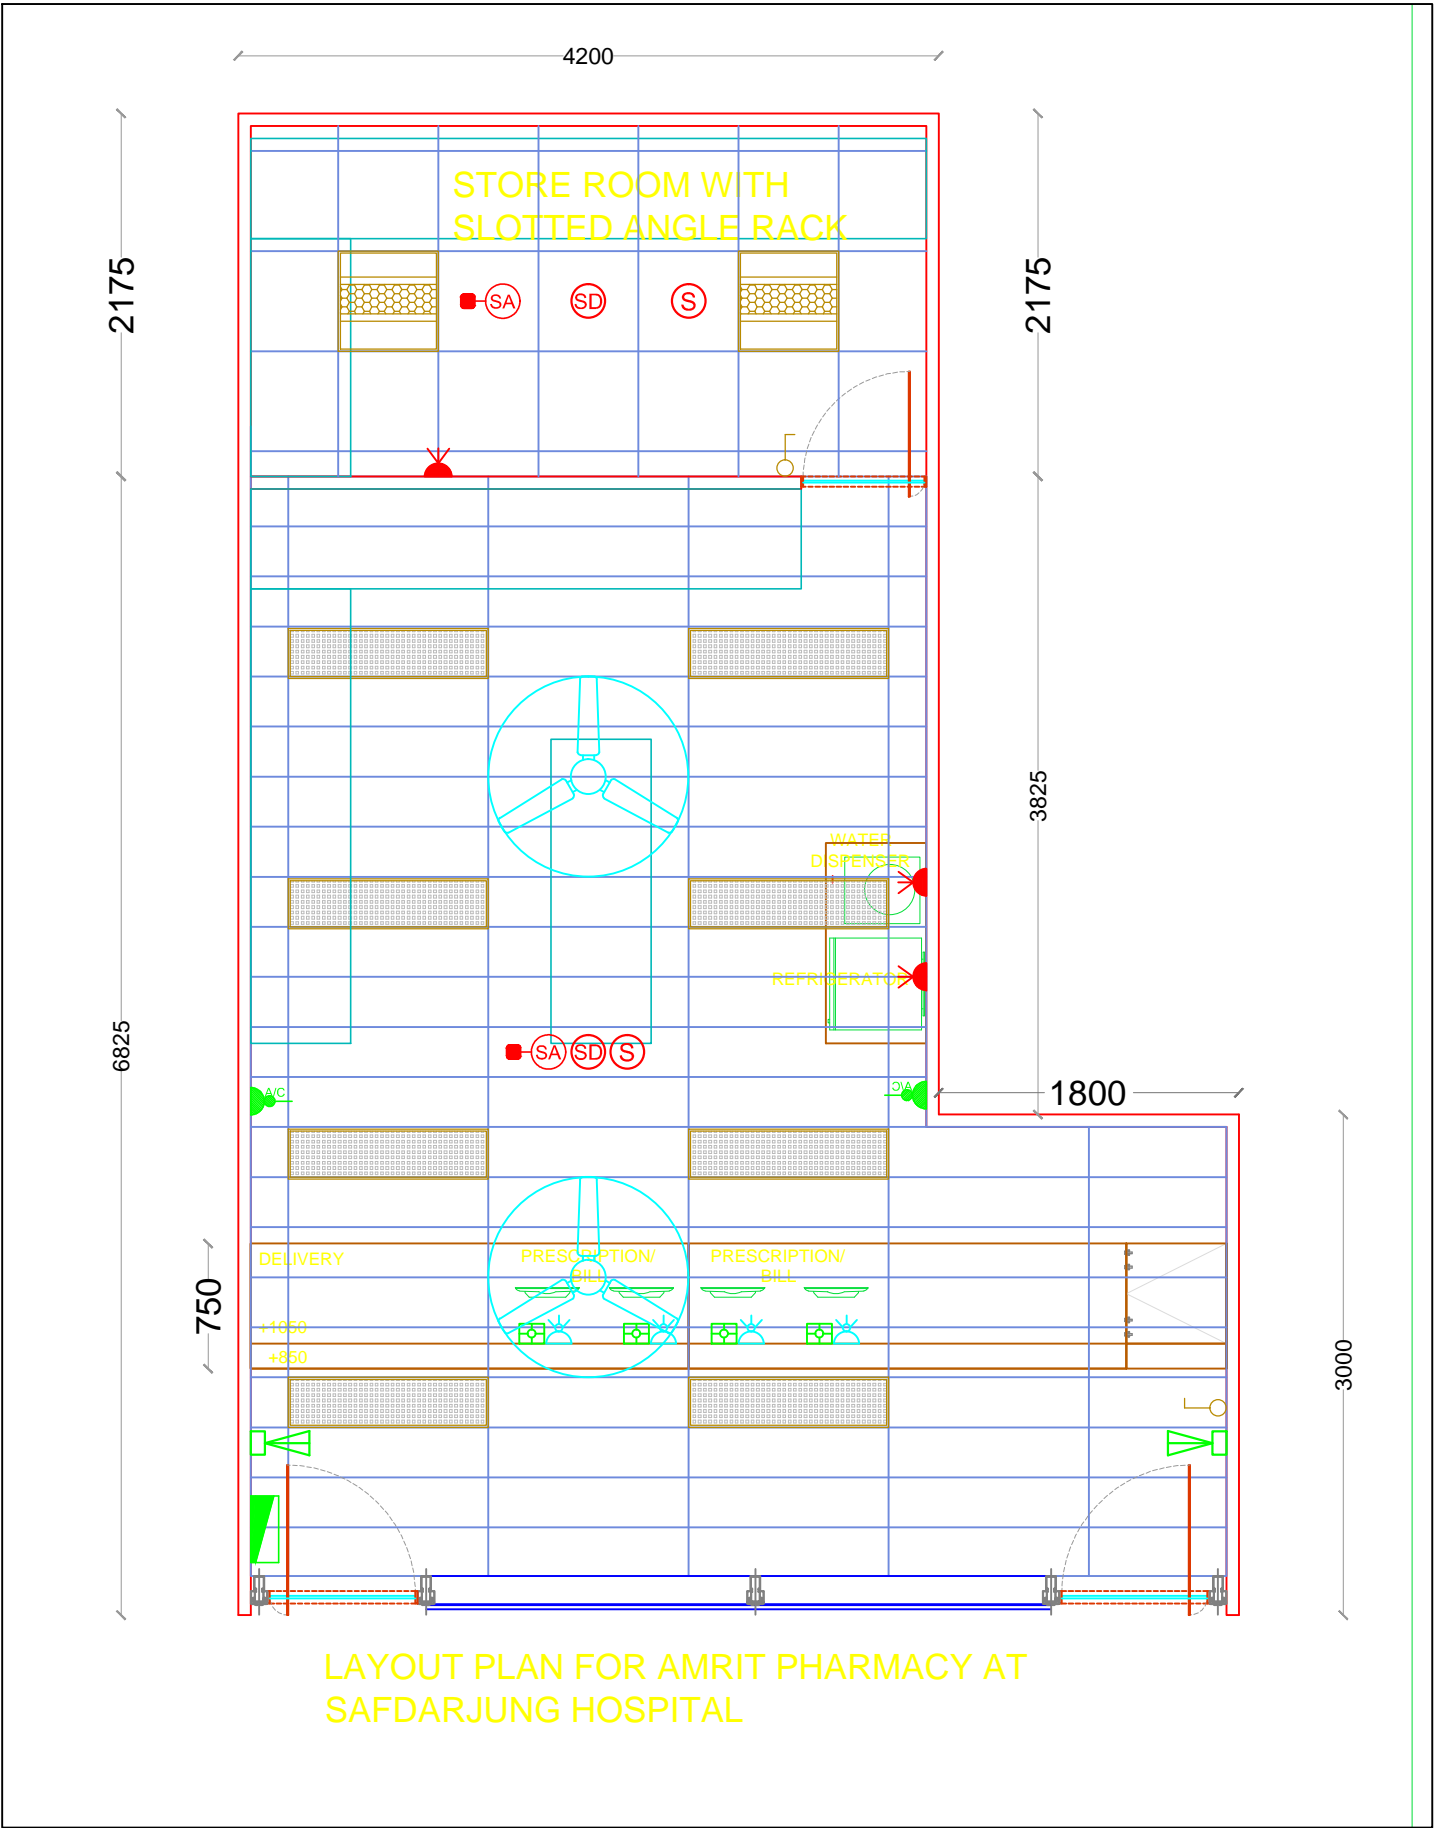


LAYOUT PLAN FOR AMRIT PHARMACY AT  
SAFDARJUNG HOSPITAL


DWG. NO. : <b>P(60) T001A</b>	REV. NO. : <b>01</b>	DMS DESIGNS C-12777, Sakunji Pk-I, Gurgaon - 122009 Email: info@dmsdesigns.co.in Web: www.dmsdesigns.co.in
DMS DESIGNS Pvt. Ltd.		
DWG. TITLE : <b>PLAN</b>	PROJECT : <b>PROPOSED LAYOUT FOR AMRIT PHARMACY DELHI</b>	
Scale : <b>1:50</b>	Checked By : <b>JC</b>	
Drawn By : <b>JS</b>		
Date : <b>02.02.16</b>	STAGE : <b>TENDER</b>	REGISTERED THIS DRAWING IS AN ORIGINAL PROPERTY OF DMS DESIGNS & CONSULTANTS PVT. LTD.

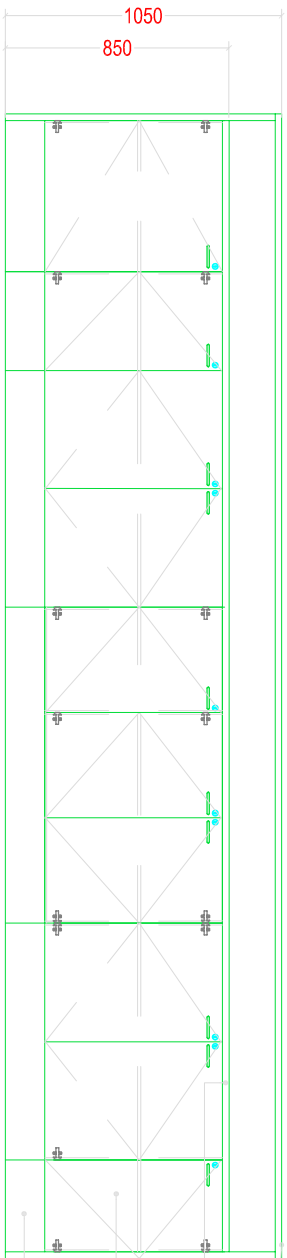

REAR ELEVATION

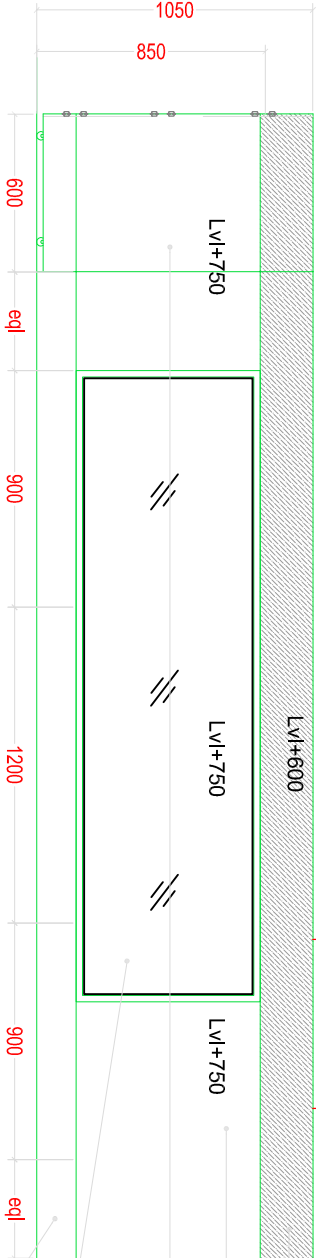

FRONT ELEVATION

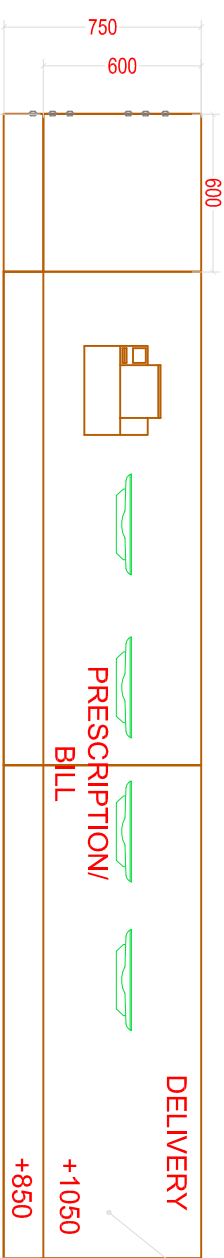

PLAN

As per site

25mm thk top with acrylic(LG Hausys-G019/Eq) finish as/app

25mm thk counter top with laminate(Greenlam-701 Rising beech/Merino / Century/Eq) finish as/app

18mm thk shutter with laminate (Greenlam-701 Rising beech/Merino / Century/Eq) finish as/app

150mm high ss laminated skirting finish as/app

Laminate finish-(Greenlam-173 Barbie pink/Merino / Century/Eq) as/app

Laminate(Greenlam-283 sky blue/Merino / Century/Eq) finish fascia as/app


600mm size movable storage unit with casters as/design

Laminated sliding shutter as/app


Display unit with 8mm glass,25mm beading all around the glass as/design

150mm highSS laminated skirting


Double level Counter of 750mm depth and Counter top at 1050mm level. 12mm thk acrylic sheet to be used for counter top on 25mm thk commercial ply. 12mm thk "L" shaped laminated strip of 150x200 to be fixed with 12mm thk ply at 850mm. Display unit with 8mm thick toughened glass fascia and 18mm thick prelaminated shelves to be inbuilt in counter as/design

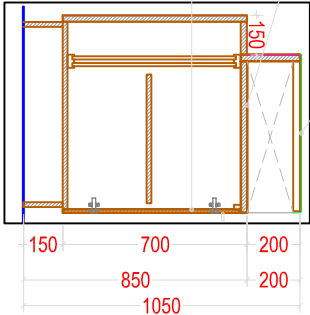


SECTION-X

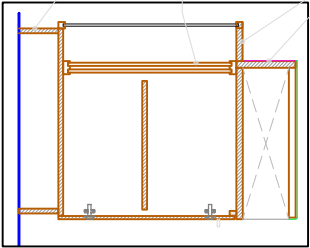


SECTION-X1

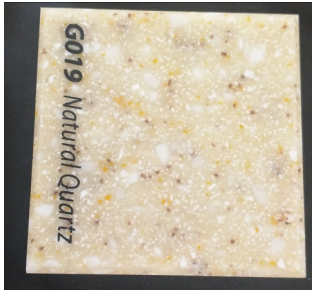

DWG NO : P(60)_DD02	REV NO : 01	DMS DESIGNS C-12777, Sustain pk-I, Gurgaon - 122009 Email:info@dmsdesigns.co In Web: www.dmsdesigns.co In
DWG TITLE : Reception Counter-Satdaring	PROJECT : PROPOSED LAYOUT FOR AMRIT PHARMACY DELHI	REGISTERED THIS DRAWING IS AN ORIGINAL PROPERTY OF DMS DESIGN'S CONSULTANTS PVT. LTD.
Scale : 1:50	Drawn By : JS	
Checked By : JC	DATE : 29.01.16	
STAGE : TENDER		

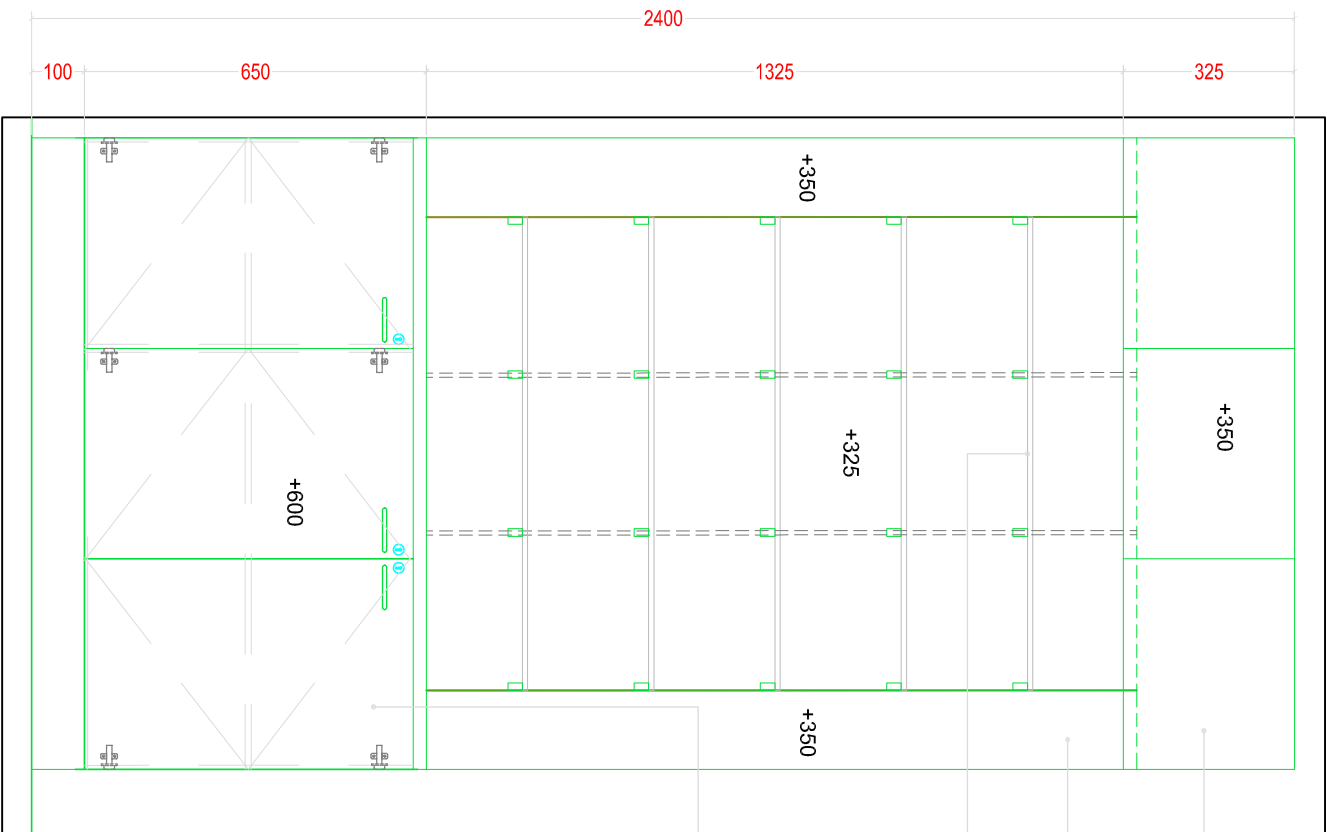


ELEVATION

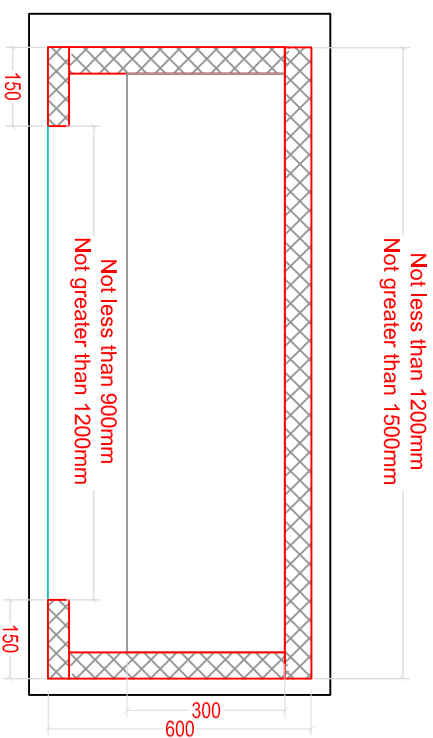

PLAN



DMS NO: P(60).DD01		REV NO: 01	<div>DMS DESIGNS C-12777, Sultan Pk-I, Gurgaon - 122009 Email: info@dmssigns.co.in Web: www.dmsigns.co.in</div> <div>: DMS<sup>®</sup> esign DESIGN CONSULTANTS</div>	
DMS TITLE: Medicine storage-Satdarjung		PROJECT: PROPOSED LAYOUT OUT FOR AMRIT PHARMACY DELHI		
Scale: 1:50		Drawn By: JS		
Checked By: JC		Date: 29.01.16		
Stage: TENDER		REGISTERED THIS DRAWING IS AN ORIGINAL PROPERTY OF DMS DESIGNS & CONSULTANTS PVT. LTD.		

