




GROUND FLOOR PLAN

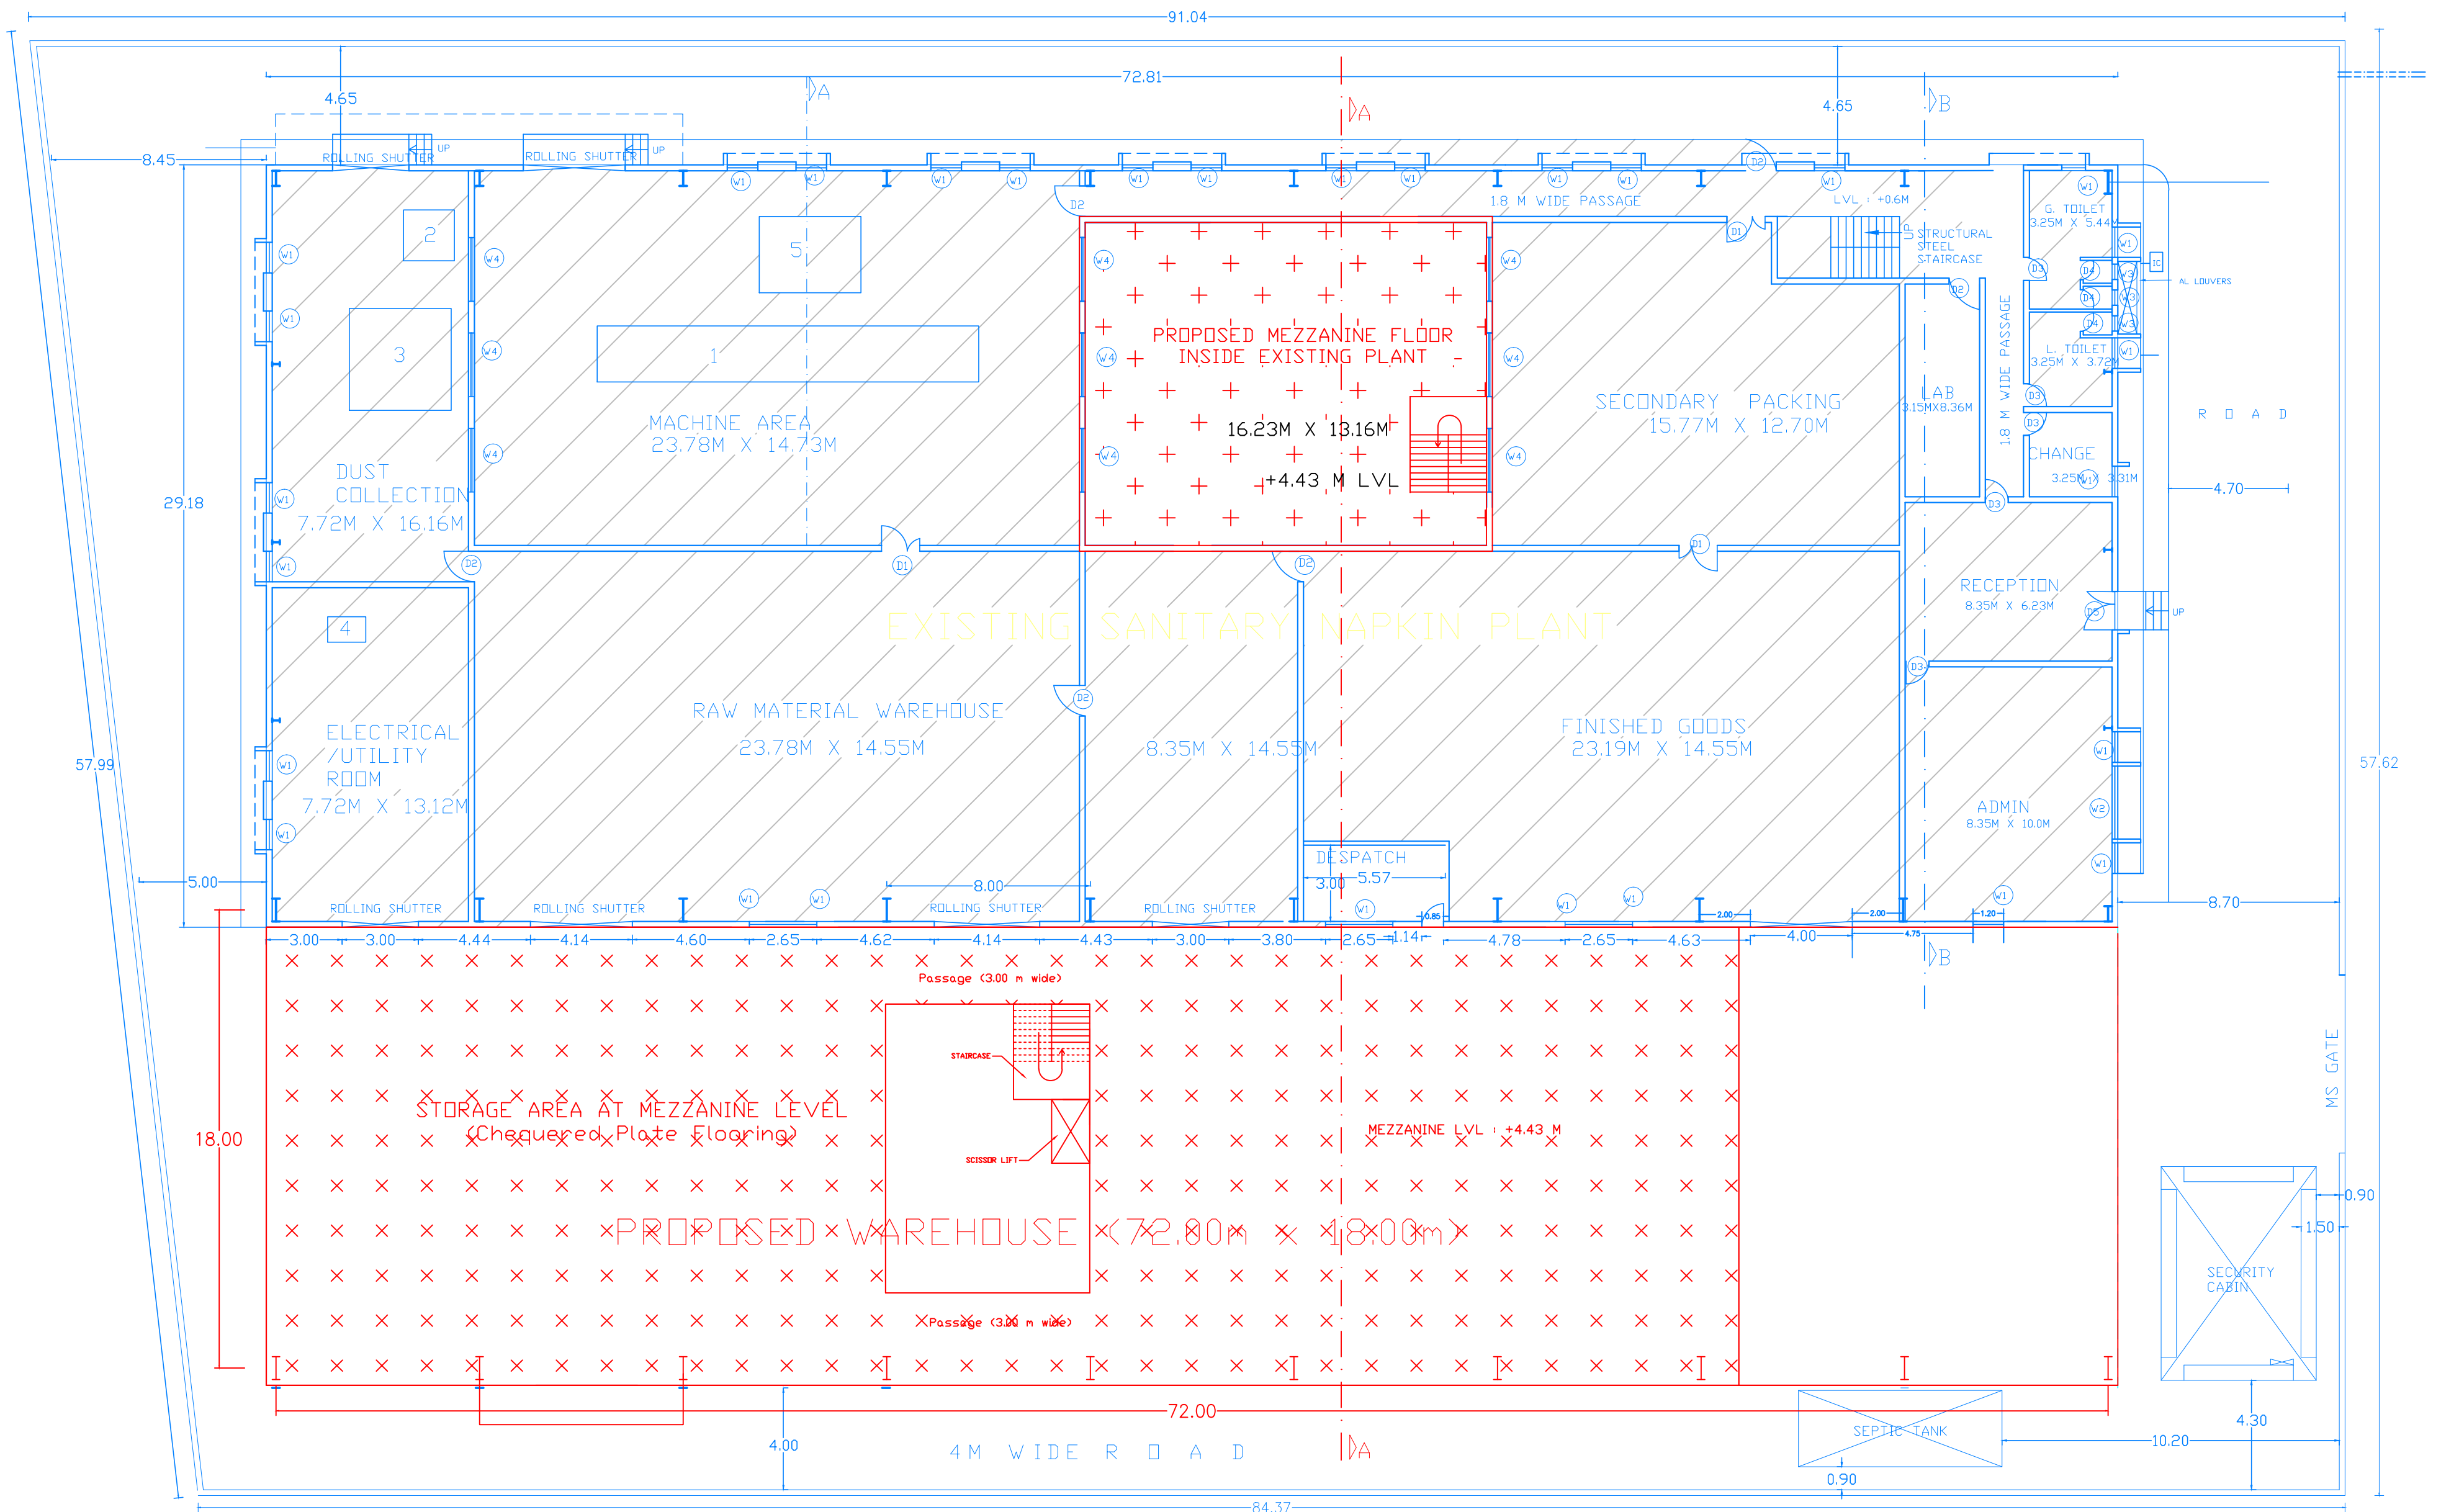

MEZZANINE FLOOR PLAN

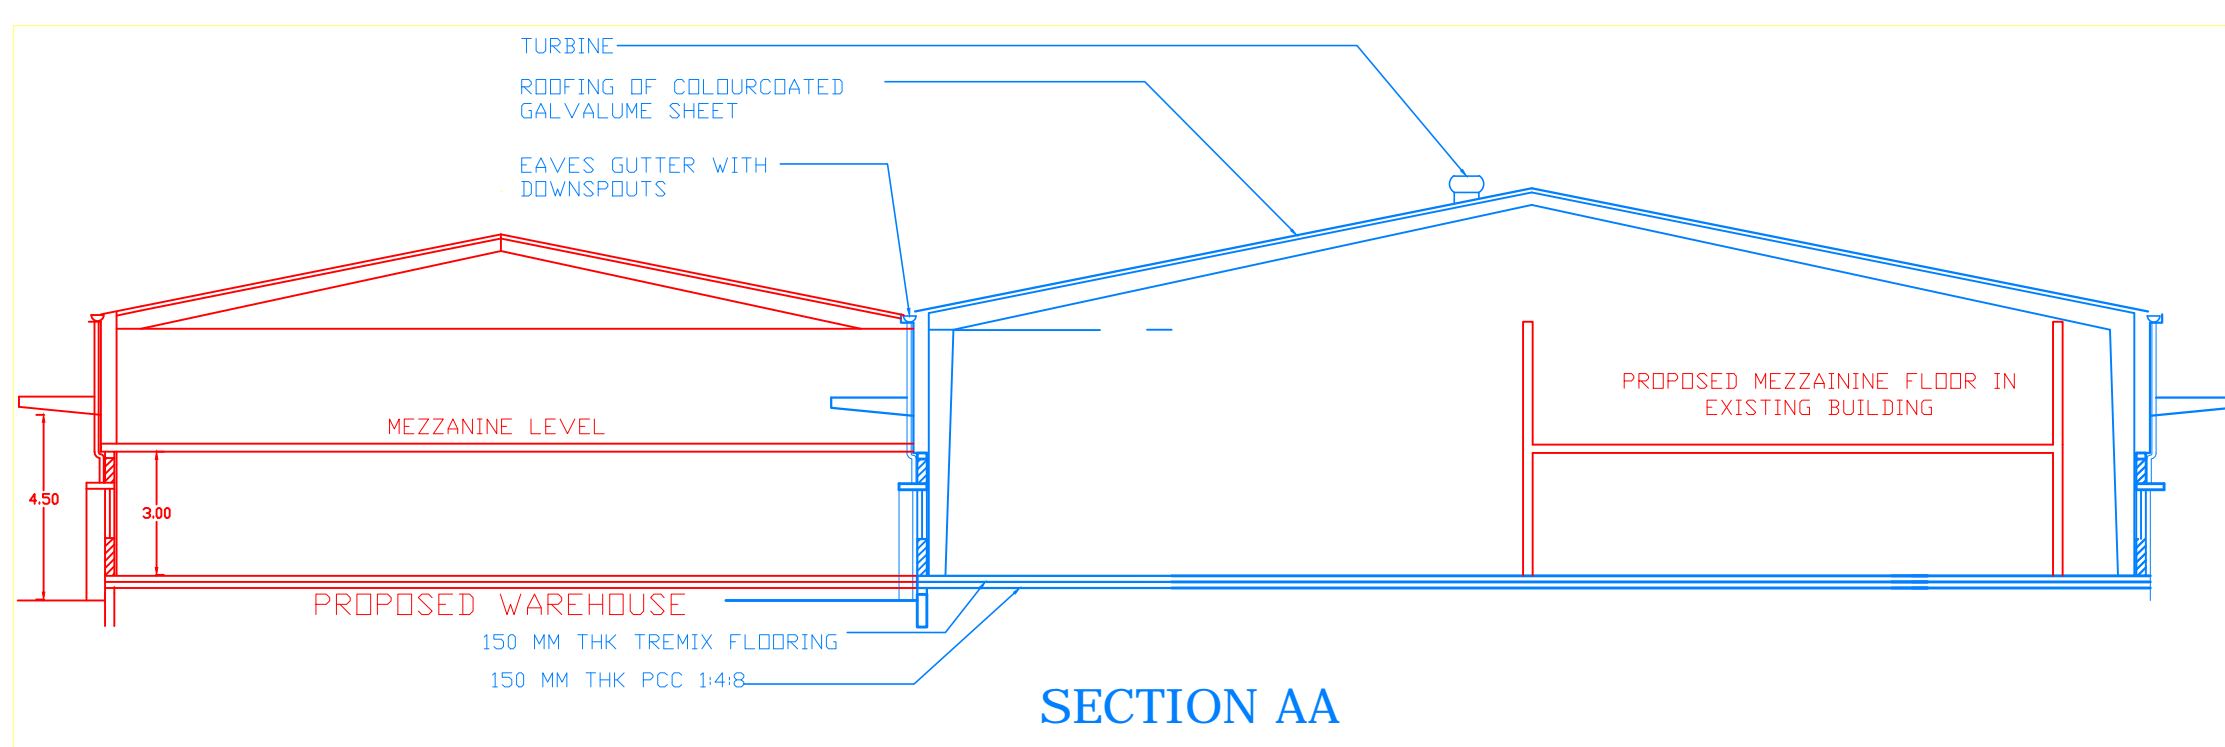

SECTION AA

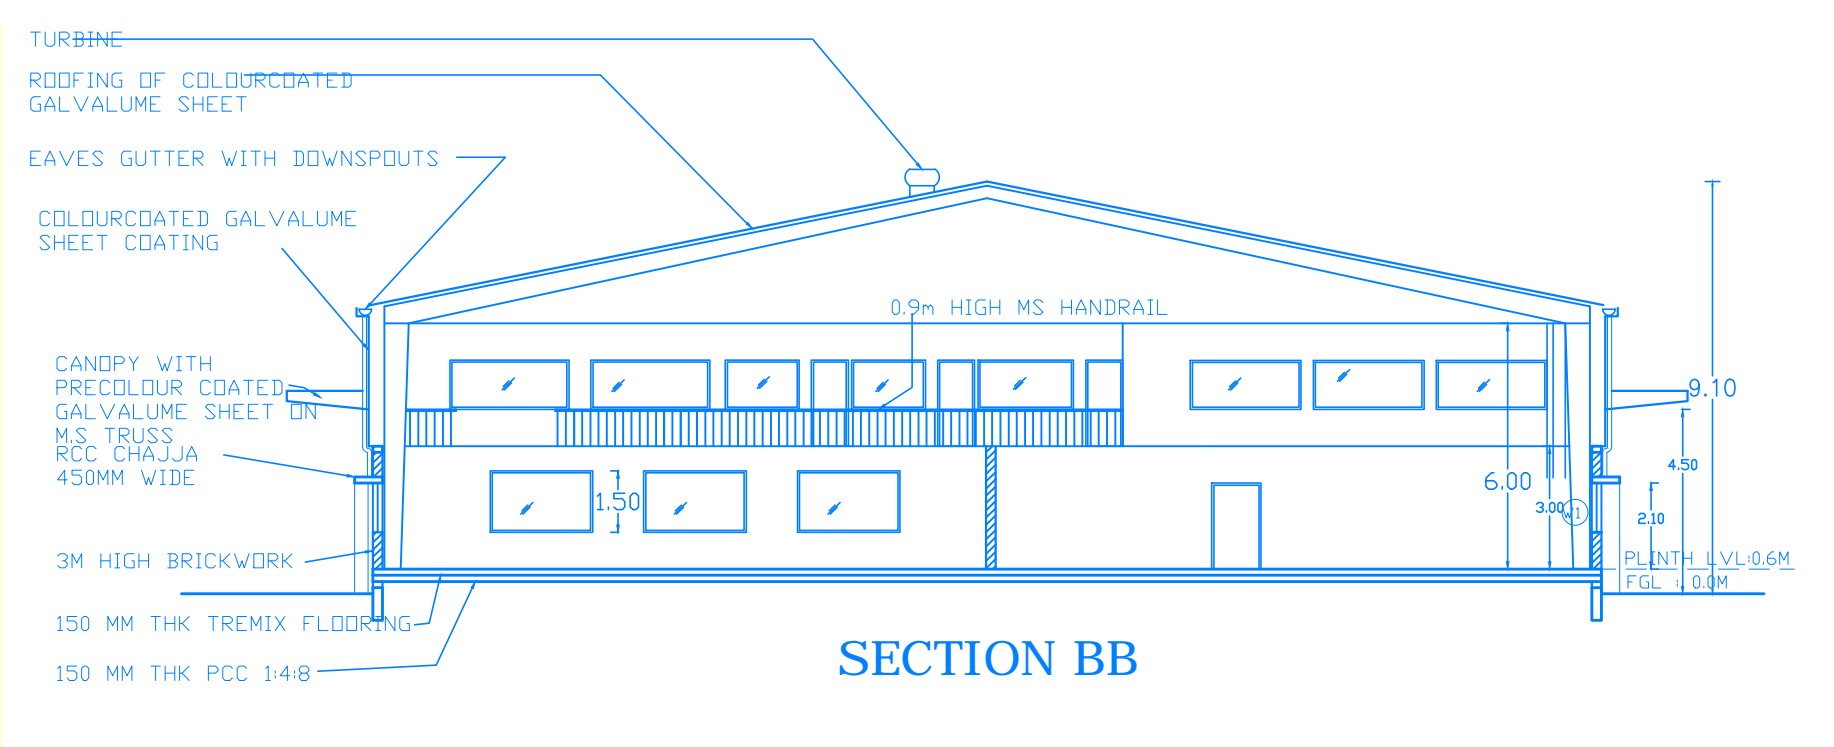

SECTION BB

<p>H.L.L. LIFE CARE LTD. (A Government of India Enterprise)</p>	<p>INFRASTRUCTURE DEVELOPMENT DIVISION VETTAMUKKU THIRUVANANTHAPURAM-6 TEL: 0471-2365872, 2365873 FAX: 0471- 2368144 web: www.hllcarehll.com</p>	<p>PROJECT:- CONSTRUCTION OF WAREHOUSE FOR SANITARY NAPKIN FACILITY AT HLL KALANGANA FACTOR, BELGAUM DRAWING:- Proposed Floor Plans and Sections</p>	<p>REVISION:</p>	<p>Drawing No. Signature</p>	
	<p>PRELIMINARY LAYOUT</p>	<p>DRAWN BY: IDD CHECKED BY:</p>	<p>SCALE: NTS DATE: 08-08-2013</p>	<p>AREA DETAILS: GROUND FLOOR = 1227 SQ.M MEZZANINE FLOOR = 1240 SQ.M</p>	<p>LEGEND: PROPOSED STRUCTURE IN RED ALL DIMENSIONS ARE IN METRES</p>