

**(A)** 1050 mm high dispensing counter. 12 mm thick Korean acrylic sheet to be used for counter on 25 mm thick commercial ply. Display unit with 18 mm thick laminated shelf's to be inbuilt in counter as/design.

**(B)** 2400 mm high storage unit. 600 mm deep and 1200mm wide laminated storage unit with 8mm thick toughened glass shelves. Shutters at bottom and top fixed with auto hinges to be provided. The ht. of 600mm deep storage shall be 750mm. 350mm deep storage unit to be fixed between two 150mm wide laminated facia. 330 mm wide 8mm thick toughened glass shelves to be fixed with bracket till 2100mm. In built overhead unit of 350 mm depth 300 mm height to be fixed above 2100mm ht. as /design

**(C)** Linear Work station (1200 x 600)

**(D.)** Movable counter with castor wheels.

NO.	DATE	DESCRIPTION	BY	CHKD.
R E V I S I O N S				

CLIENT





PROJECT TITLE  
**PROPOSED AMRIT PHARMACY  
 AT AIIMS BHUBANESWAR**

CLIENT'S SIGNATURE      ARCHITECT'S SIGNATURE

DRAWING TITLE  
**PROPOSED AMRIT PHARMACY  
 AT AIIMS BHUBANESWAR  
 LAYOUT PLAN**

DATE: 17-06-2016      SCALE 1:100

DRG. NUMBER      REV.  
 AMR/ BHA /002      001

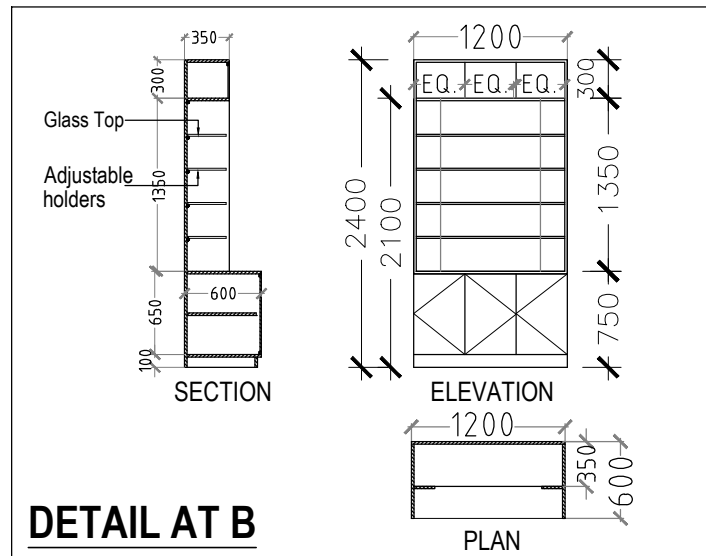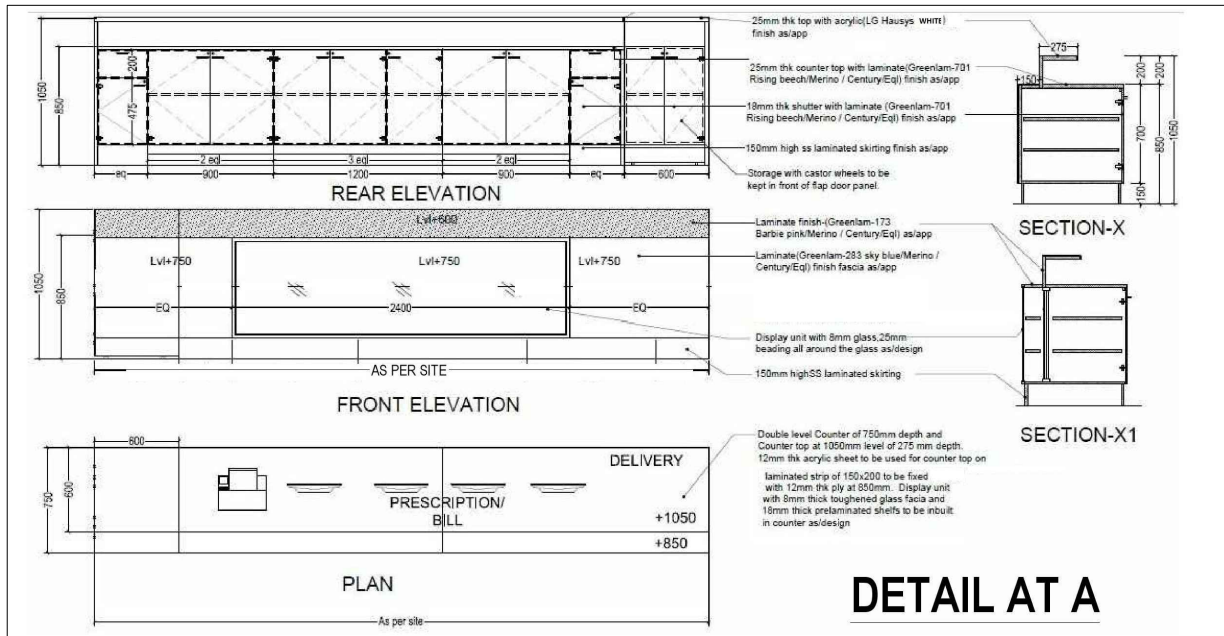

NOS.	DATE	DESCRIPTION	DWN	CHKD.

REVISIONS

CLIENT



PROJECT TITLE  
**PROPOSED AMRIT PHARMACY AT AIIMS BHUBANESWAR**

CLIENT'S SIGNATURE

ARCHITECT'S SIGNATURE


DRAWING TITLE  
**FURNITURE DETAIL**

DATE: 17-06-2016

SCALE

DRG. NUMBER  
**AMR/ PAT/001**

REV  
**004**

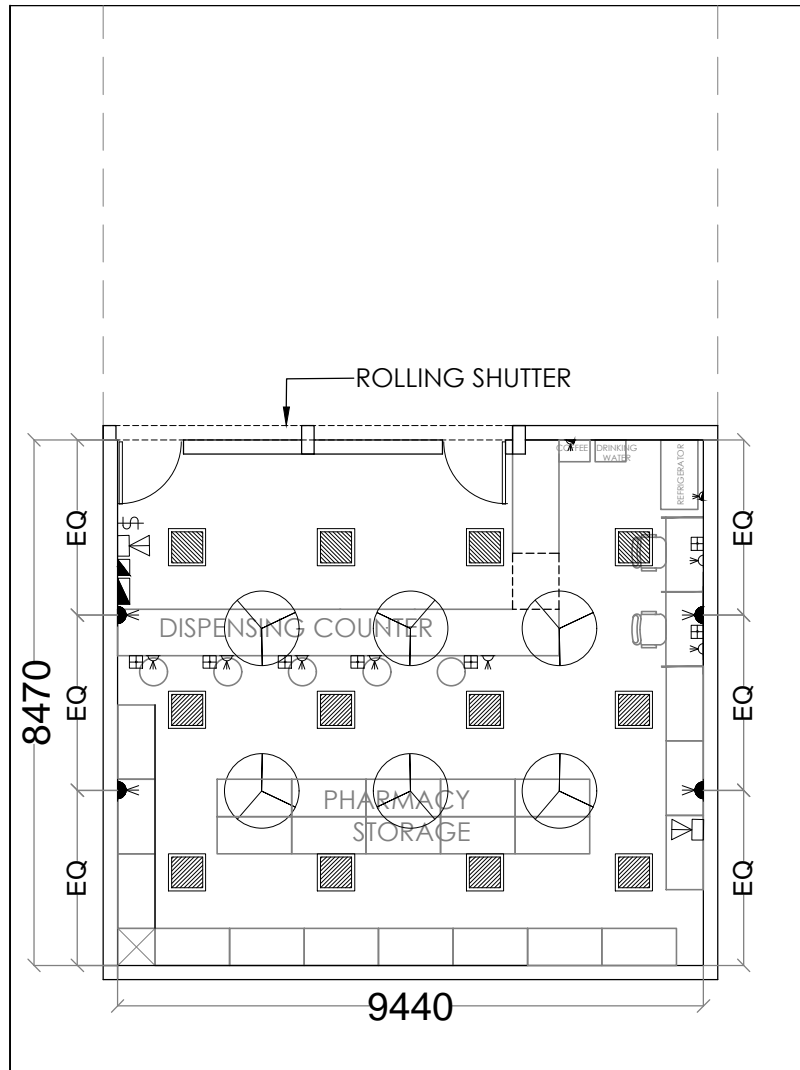

Sym.	Descr.
	SWITCH BOARD
	5 A / 6 A LIGHT PLUG
	20 A TPN POWER SOCKET
	5/6 A SOCKET OUT-LET UPS 2NOS. WITH 1 NO. 16 A SOCKET OUT-LET
	15/16 A SOCKET OUT
	CCTV CAMERA
	600 X 600 RECESS LIGHT
	DATA & TELEPHONE OUTLET
	DISTRIBUTION BOX
	UPS BOX

NO.	DATE	DESCRIPTION	BY	CHKD.
R E V I S I O N S				

CLIENT



PROJECT TITLE  
**PROPOSED AMRIT PHARMACY  
 AT AIIMS BHUBANESWAR**

CLIENT'S SIGNATURE

ARCHITECT'S SIGNATURE

DRAWING TITLE  
**PROPOSED AMRIT PHARMACY  
 AT AIIMS BHUBANESWAR  
 ELECTRICAL LAYOUT**

DATE: 17-06-2016

SCALE: 1:100

DRG. NUMBER  
 AMR/ BHA /003

REV.  
 001